


THE DESIGN AND DETAILS DISCLOSED HEREIN ARE THE EXCLUSIVE PROPERTY OF CARLIN MANUFACTURING LLC. AND SHALL NOT BE COPIED OR REPRODUCED IN WHOLE OR IN PART WITHOUT THE PRIOR WRITTEN CONSENT OF CARLIN MANUFACTURING LLC. © 2006 CARLIN MANUFACTURING LLC.

REVISIONS				
ZONE	REV	DESCRIPTION	DATE	APPROVED

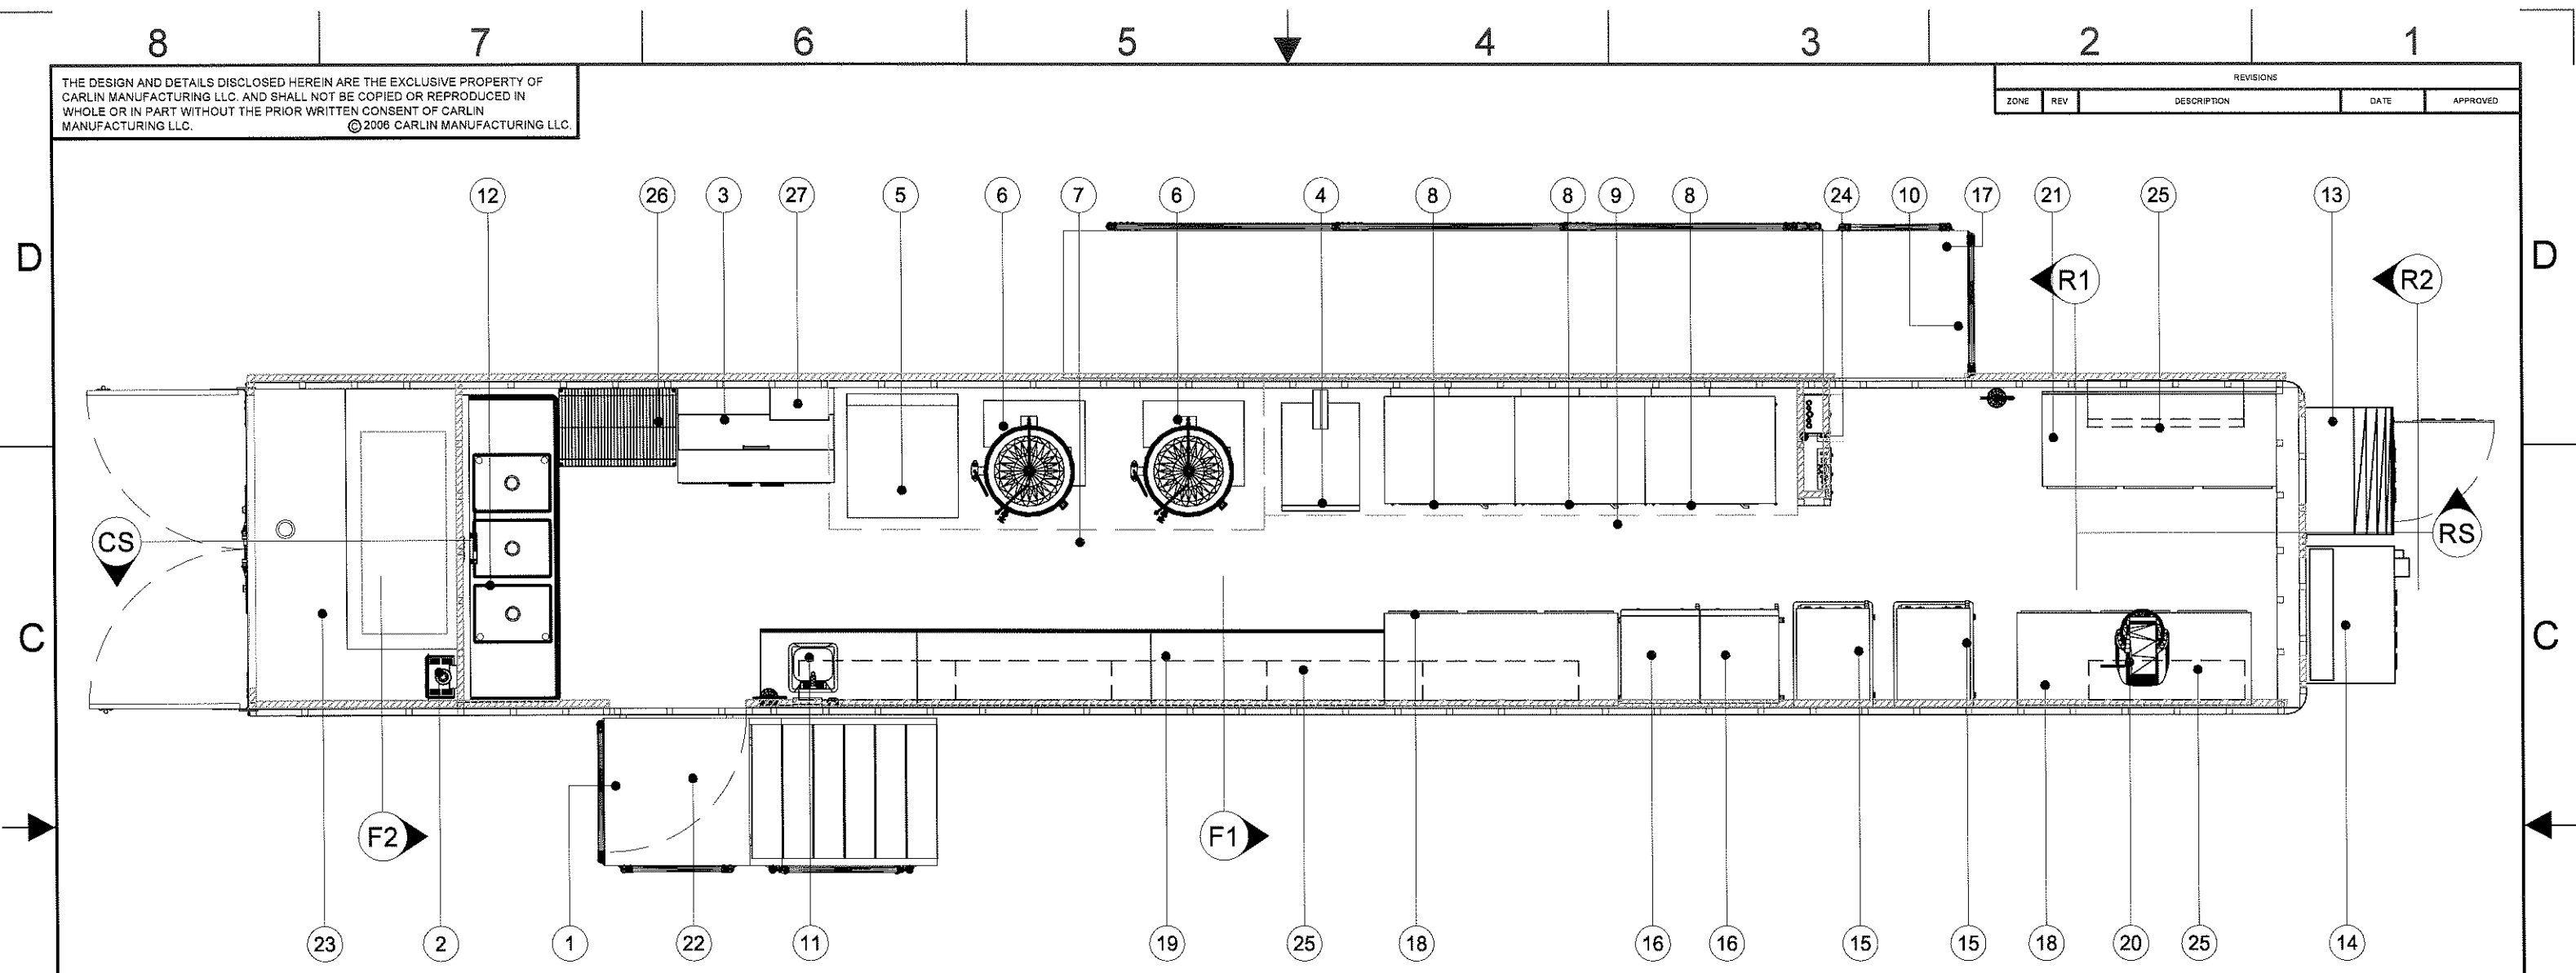

**EQUIPMENT LIST:**

- |   |  |                            |
|---|--|----------------------------|
| 1. ENTRY DOOR                           | 12. 3-COMPARTMENT SINK                                     | 23. GENERATOR COMPARTMENT  |
| 2. WATER HEATER                         | 13. MAKEUP AIR   | 24. ELECTRICAL PANEL       |
| 3. REFRIGERATED PREP TABLE              | 14. HVAC UNIT  | 25. SSSL OVERHEAD SHELVING |
| 4. DUAL STACK STEAMER                   | 15. HOT FOOD CABINET                                       | 26. 24" X 36" METRO SHELF  |
| 5. FRENCH TOP RANGE W/ 3 OPEN BURNERS   | 16. COOK & HOLD FOOD CABINET                               | 27. ANSUL SYSTEM           |
| 6. 40 GAL KETTLE                        | 17. PLATFORM W/ STAIRS                                     | 28. FIRE EXTINGUISHER      |
| 7. SSSL CANOPY HOOD                     | 18. UNDER COUNTER REFRIGERATOR                             |                            |
| 8. DUAL STACK CONVECTION OVEN           | 19. SSSL COUNTER W/ UNDER SHELF                            |                            |
| 9. SSSL BOX HOOD                        | 20. 20QT. MIXER  |                            |
| 10. ENTRY DOOR                          | 21. 6' MARBLE TOP PREP TABLE W/ UNDER COUNTER REFRIGERATOR |                            |
| 11. HAND SINK W/ SOAP & TOWEL DISPENSER | 22. PLATFORM W/ RAMP                                       |                            |

**Kitchens To Go**

F & B CATERING  
53' TRAILER

UNLESS OTHERWISE SPECIFIED DIMENSIONS ARE IN INCHES TOLERANCES ARE:  
FRACTIONS DECIMALS  
FRAC<sup>+</sup> 1/16 XX<sup>+</sup> ± .06  
ANG ± 5' XXX<sup>+</sup> ± .005

DO NOT SCALE DRAWINGS

DRAWINGS PREPARED IN ACCORDANCE WITH MIL-T-3100, MIL-STD-100, AND ANSI Y14.5

SCALE 1/4" = 1' - 0"

**FLOOR PLAN**

UNIT NO. 773

**CARLIN MANUFACTURING LLC**

FLOOR PLAN AND EQUIPMENT LIST

APPROVALS DATE 02-06-06

DRAWN GSF

CHECKED

ENGR

DESIGN ACTIVITY

REV.

SCALE 1/4" = 1' - 0"

DWG. NO. 773A01-0-01

SIZE B

SHEET